


**NOTES:**

- Verify all dimensions, elevations, and datum references prior to construction.
- All drawings remain the property of the designer.
- This design and drawing may not be reproduced without permission of the designer.
- Do not scale drawings.
- This drawing supersedes previous issues.

**PRIME:**

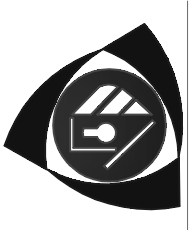

**Greensmart HOMES**  
Sustainable Housing

**CONSULTANT:**  
Buildtech Resources Ltd.  
P: (780) 951-9449 F: (780) 455-3393  
buildtech@airsurfer.ca

**CONSULTANT:**

**REVISIONS:**


DATE	DESCRIPTION	BY

- DRAWING REFERENCE SYMBOLS:**
- ① — DETAIL NUMBER REFERENCE
  - ①.1 — DRAWING NUMBER WHERE LOCATED
  - ①.1 — SECTION DETAIL REFERENCE
  - ①.1 — DRAWING NUMBER WHERE LOCATED
  - ①.1 — BUILDING SECTION REFERENCE
  - ①.1 — DRAWING NUMBER WHERE LOCATED
  - ①.1 — DRAWING NUMBER
  - ①.1 — DRAWING NUMBER WHERE LOCATED

**MODEL:** 12x40'  
**PROJECT:** (name/legal description)

**TITLE:** GSM TRAILER  
**FLOOR PLAN**

**SCALE:** AS NOTED  
**JOB NO.:** J27-410  
**DRAWN:** ZC  
**DATE:** Aug. 3, 07  
**SHEET:** S.1

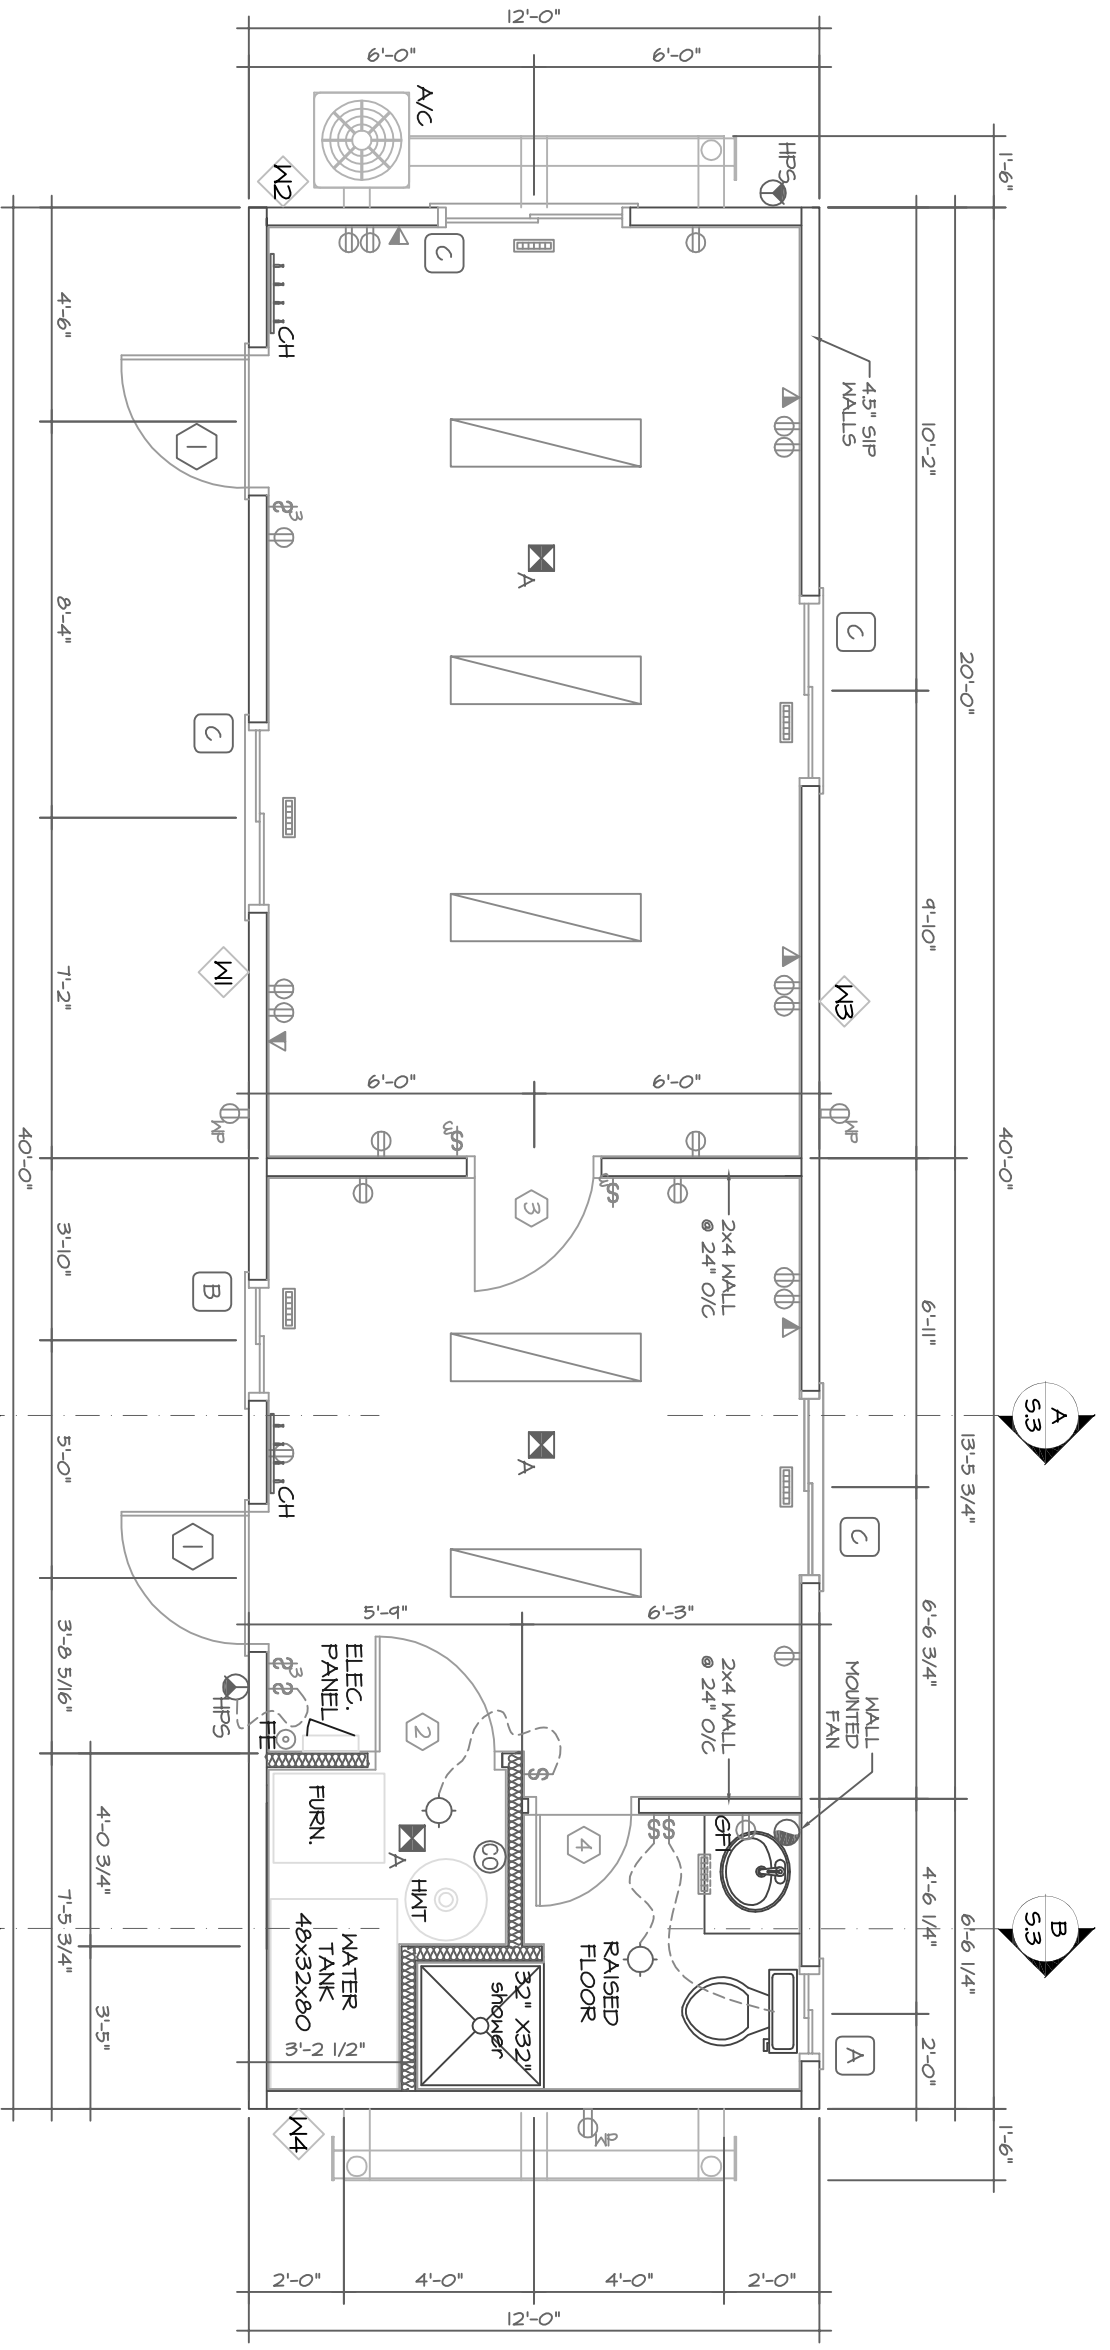

**FLOOR PLAN**  
SCALE: 1/4"=1'-0"

**DOOR SCHEDULE**

SYMBOL	WIDTH X HEIGHT	TYPE	QNT	NOTES
①	36" x 80"	STEEL INSULATED	2	20" x 20" LITE, panic hardware
②	30" x 80"	SOLID CORE WOOD	1	FIRE RATED
③	32" x 80"	SOLID CORE WOOD	1	
④	28" x 80"	SOLID CORE WOOD	1	

**WINDOW SCHEDULE**

SYMBOL	WIDTH X HEIGHT	ROUGH OPENING	QNT
A	24" x 24"	24-5/8X24-5/8	1
B	30"X30"	30-1/2X30-1/2	1
C	48" x 36"	48-1/4X36-3/8	4

**LEGEND**

SYMBOL	DESCRIPTION	SYMBOL	DESCRIPTION
\$	15A/125V SINGLE POLE SWITCH	Ⓞ	120VAC CARBON MONOXIDE DETECTOR
\$	15A/125V 3-WAY SWITCH	Ⓜ	WALL MOUNTED EXHAUST FAN
\$	15A/125V DUPLEX RECEPTACLE	Ⓜ	TV OUTLET
\$	SPLIT WIRED 15A/125V DUPLEX RECEPTACLE	Ⓜ	TELEPHONE INTERNET
Ⓜ	WEATHER PROOF RECEPTACLE	Ⓜ	RECESSED TOW HIGH PRESSURE SODIUM, WALL MOUNT LIGHT
Ⓜ	CIRCUIT INTERRUPT RECEPTACLE	Ⓜ	WALL SCONCE
Ⓜ	FIRE EXTINGUISHER	Ⓜ	4' FLUORESCENT SURFACE MTD STRIP FIXTURE 2 LAMP
Ⓜ	120VAC SMOKE ALARM, INTERCONNECTED	Ⓜ	1"φ HOLE ON EXTERIOR THROUGH TO CHASE
Ⓜ	WEATHER PROOF DISCONNECT	Ⓜ	INCANDESCENT LIGHT FIXTURE
Ⓜ	JUNCTION BOX SIZE AS REQ'D	Ⓜ	INCANDESCENT POT LIGHT FIXTURE